

REVISIONS	DATE
REVISION No. 2	1-25-91
ADD NEW SINKS	3-28-91


STANTON & ASSOCIATES
 98 Battery Street
 San Francisco, CA 94111
 (415) 433-1334

Tommy Ma and Associates
 15
 1111 Broadway, Suite 711, S.F., CA 94108
 (415) 774-1000

Jorda
 WATSONVILLE

PLUMBING
UPPER FLOOR PLAN

Date: 2-4-91
 Scale: 1/8"=1'-0"
 Drawn:
 Job:
 Sheet . of Sheet
P-1

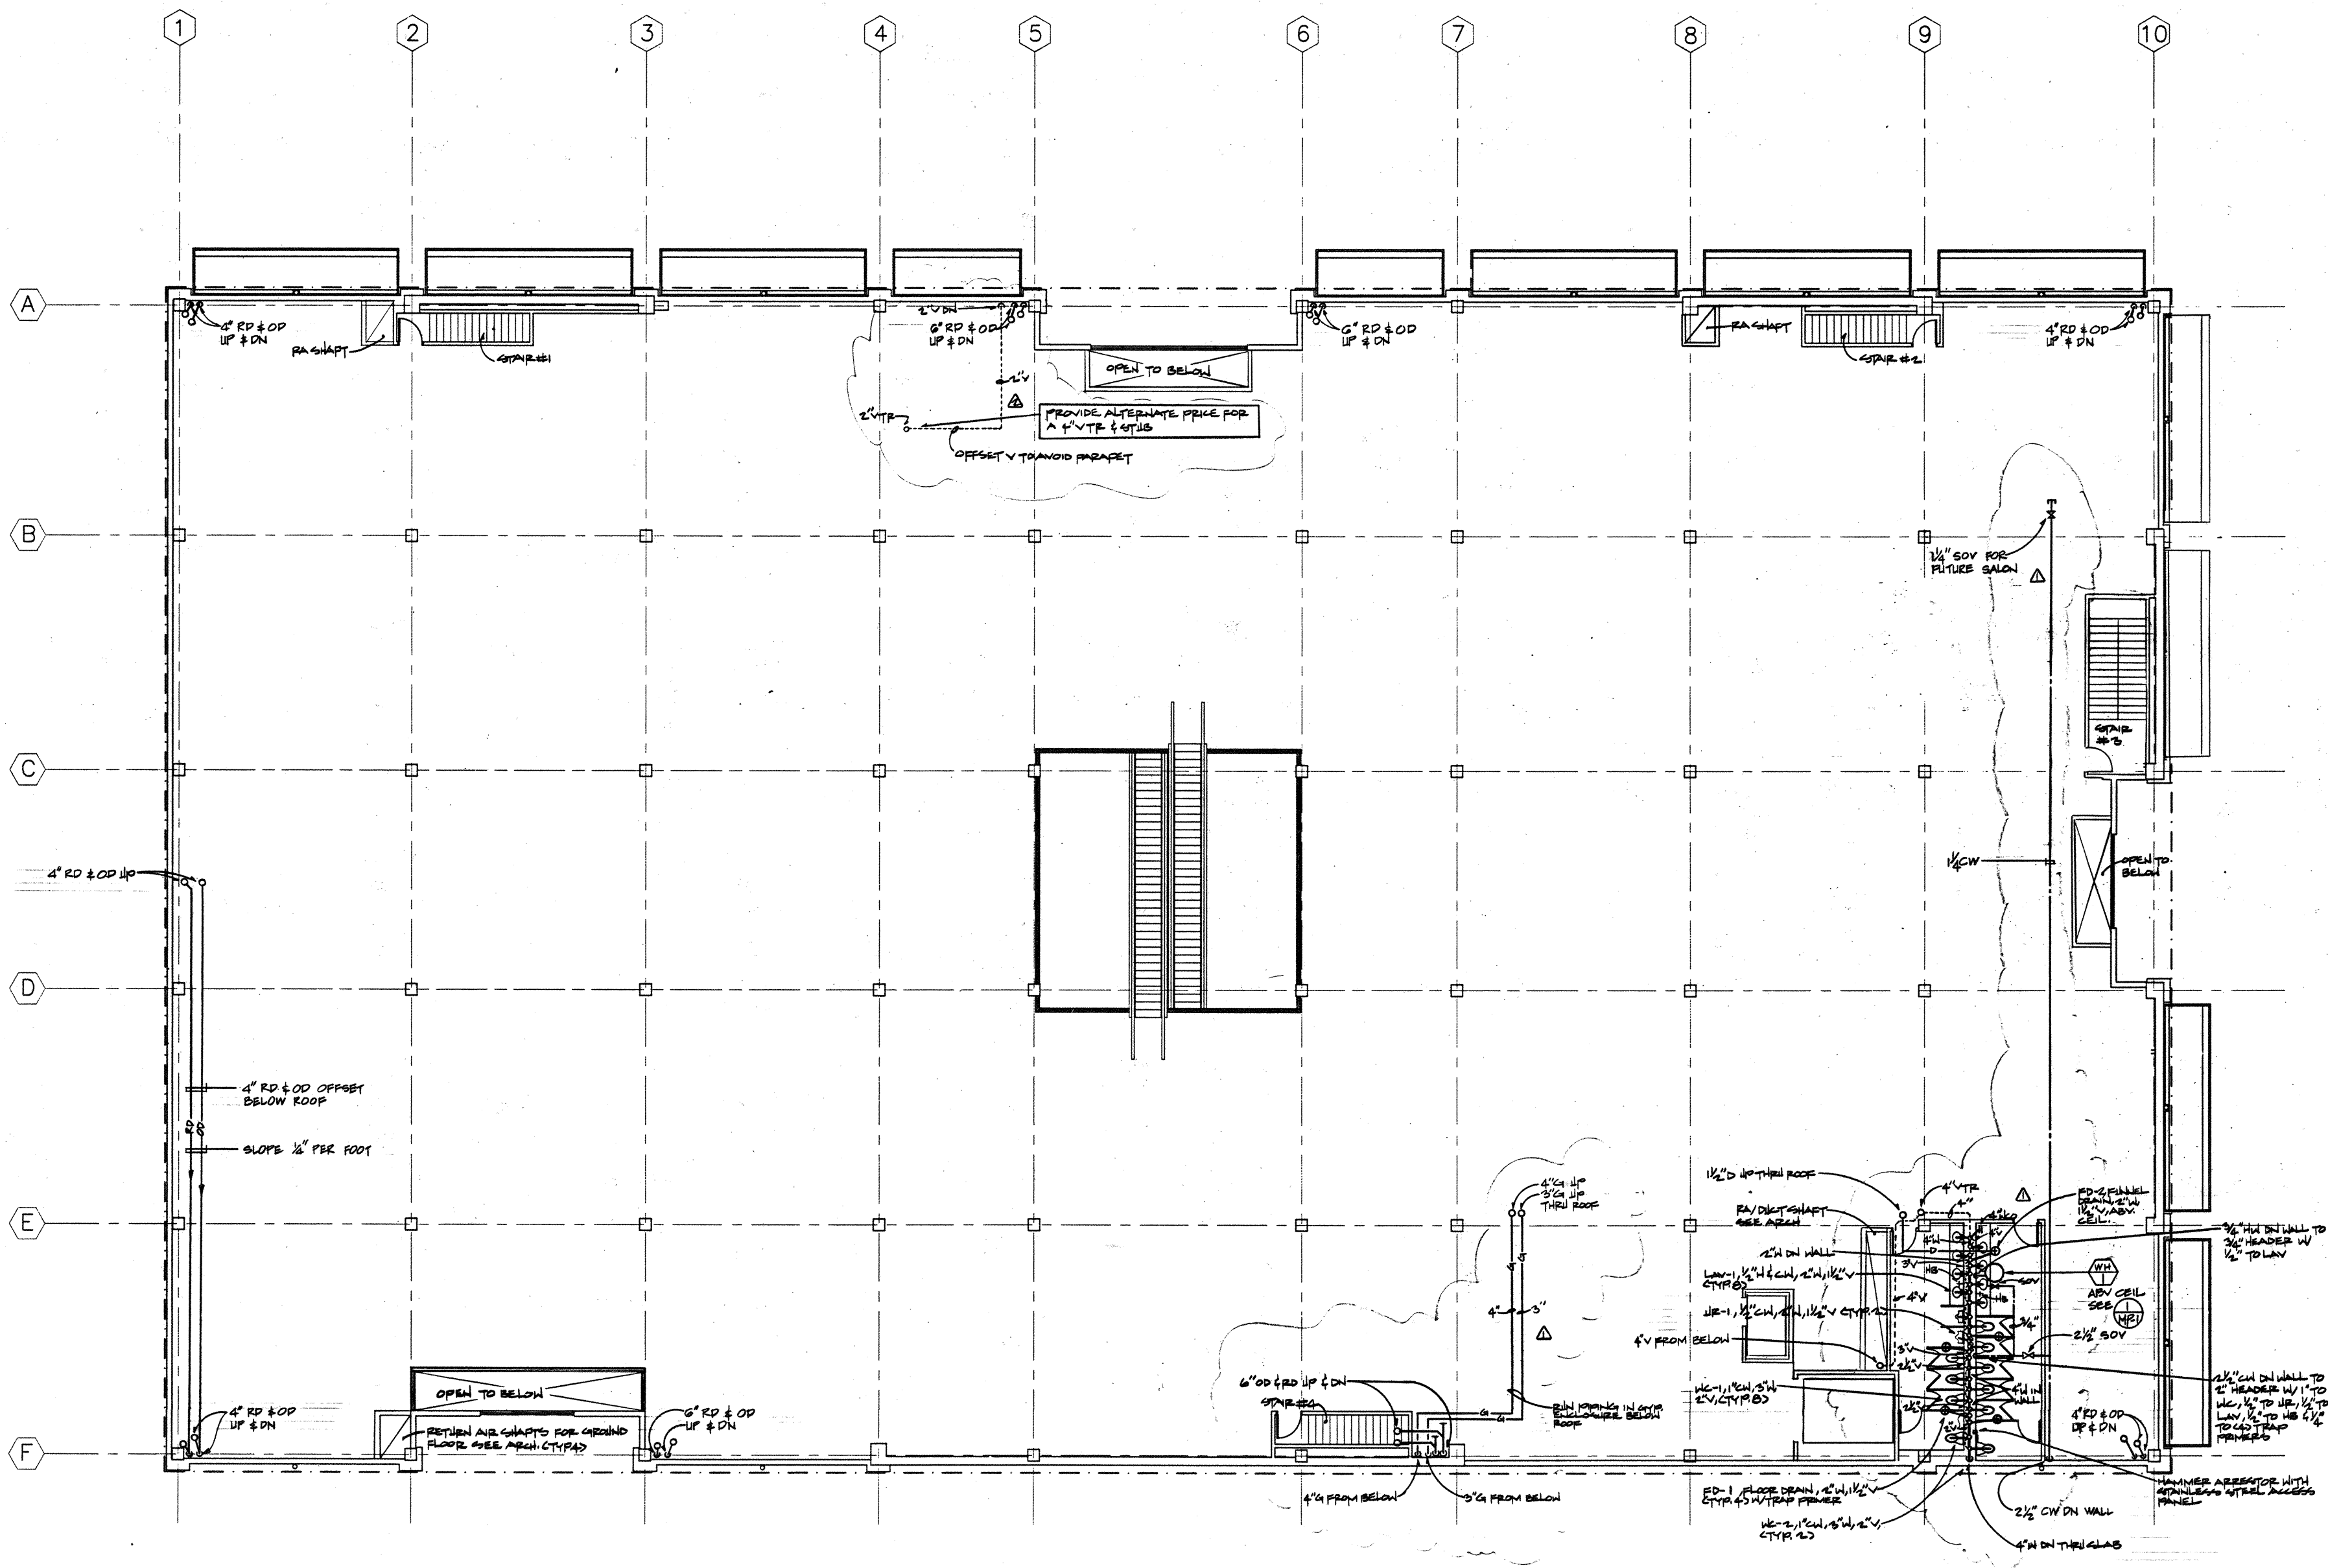

UPPER FLOOR PLAN - PLUMBING ①
 1/8"=1'-0"

REFERENCE NORTH



SHELL CONSTRUCTION SET

PROJ
 JOB#
 DISK
 FILE
 DATE

REVISIONS	DATE
1	1-24-91
2	2-4-91
3	3-8-91
4	3-13-91
5	4-1-91


STANTON & ASSOCIATES
 98 Battery Street
 San Francisco, CA 94111
 (415) 433-1334

TERRY SHINE-CHOW
 Mechanical Engineer, State Reg. No. 19493
 (415) 433-1334

Ford's
 WATSONVILLE

PLUMBING
GROUND FLOOR PLAN

Date: 2-4-91
 Scale: 1/8"=1'-0"
 Draw:
 Job:
 Sheet: of 3
P-2

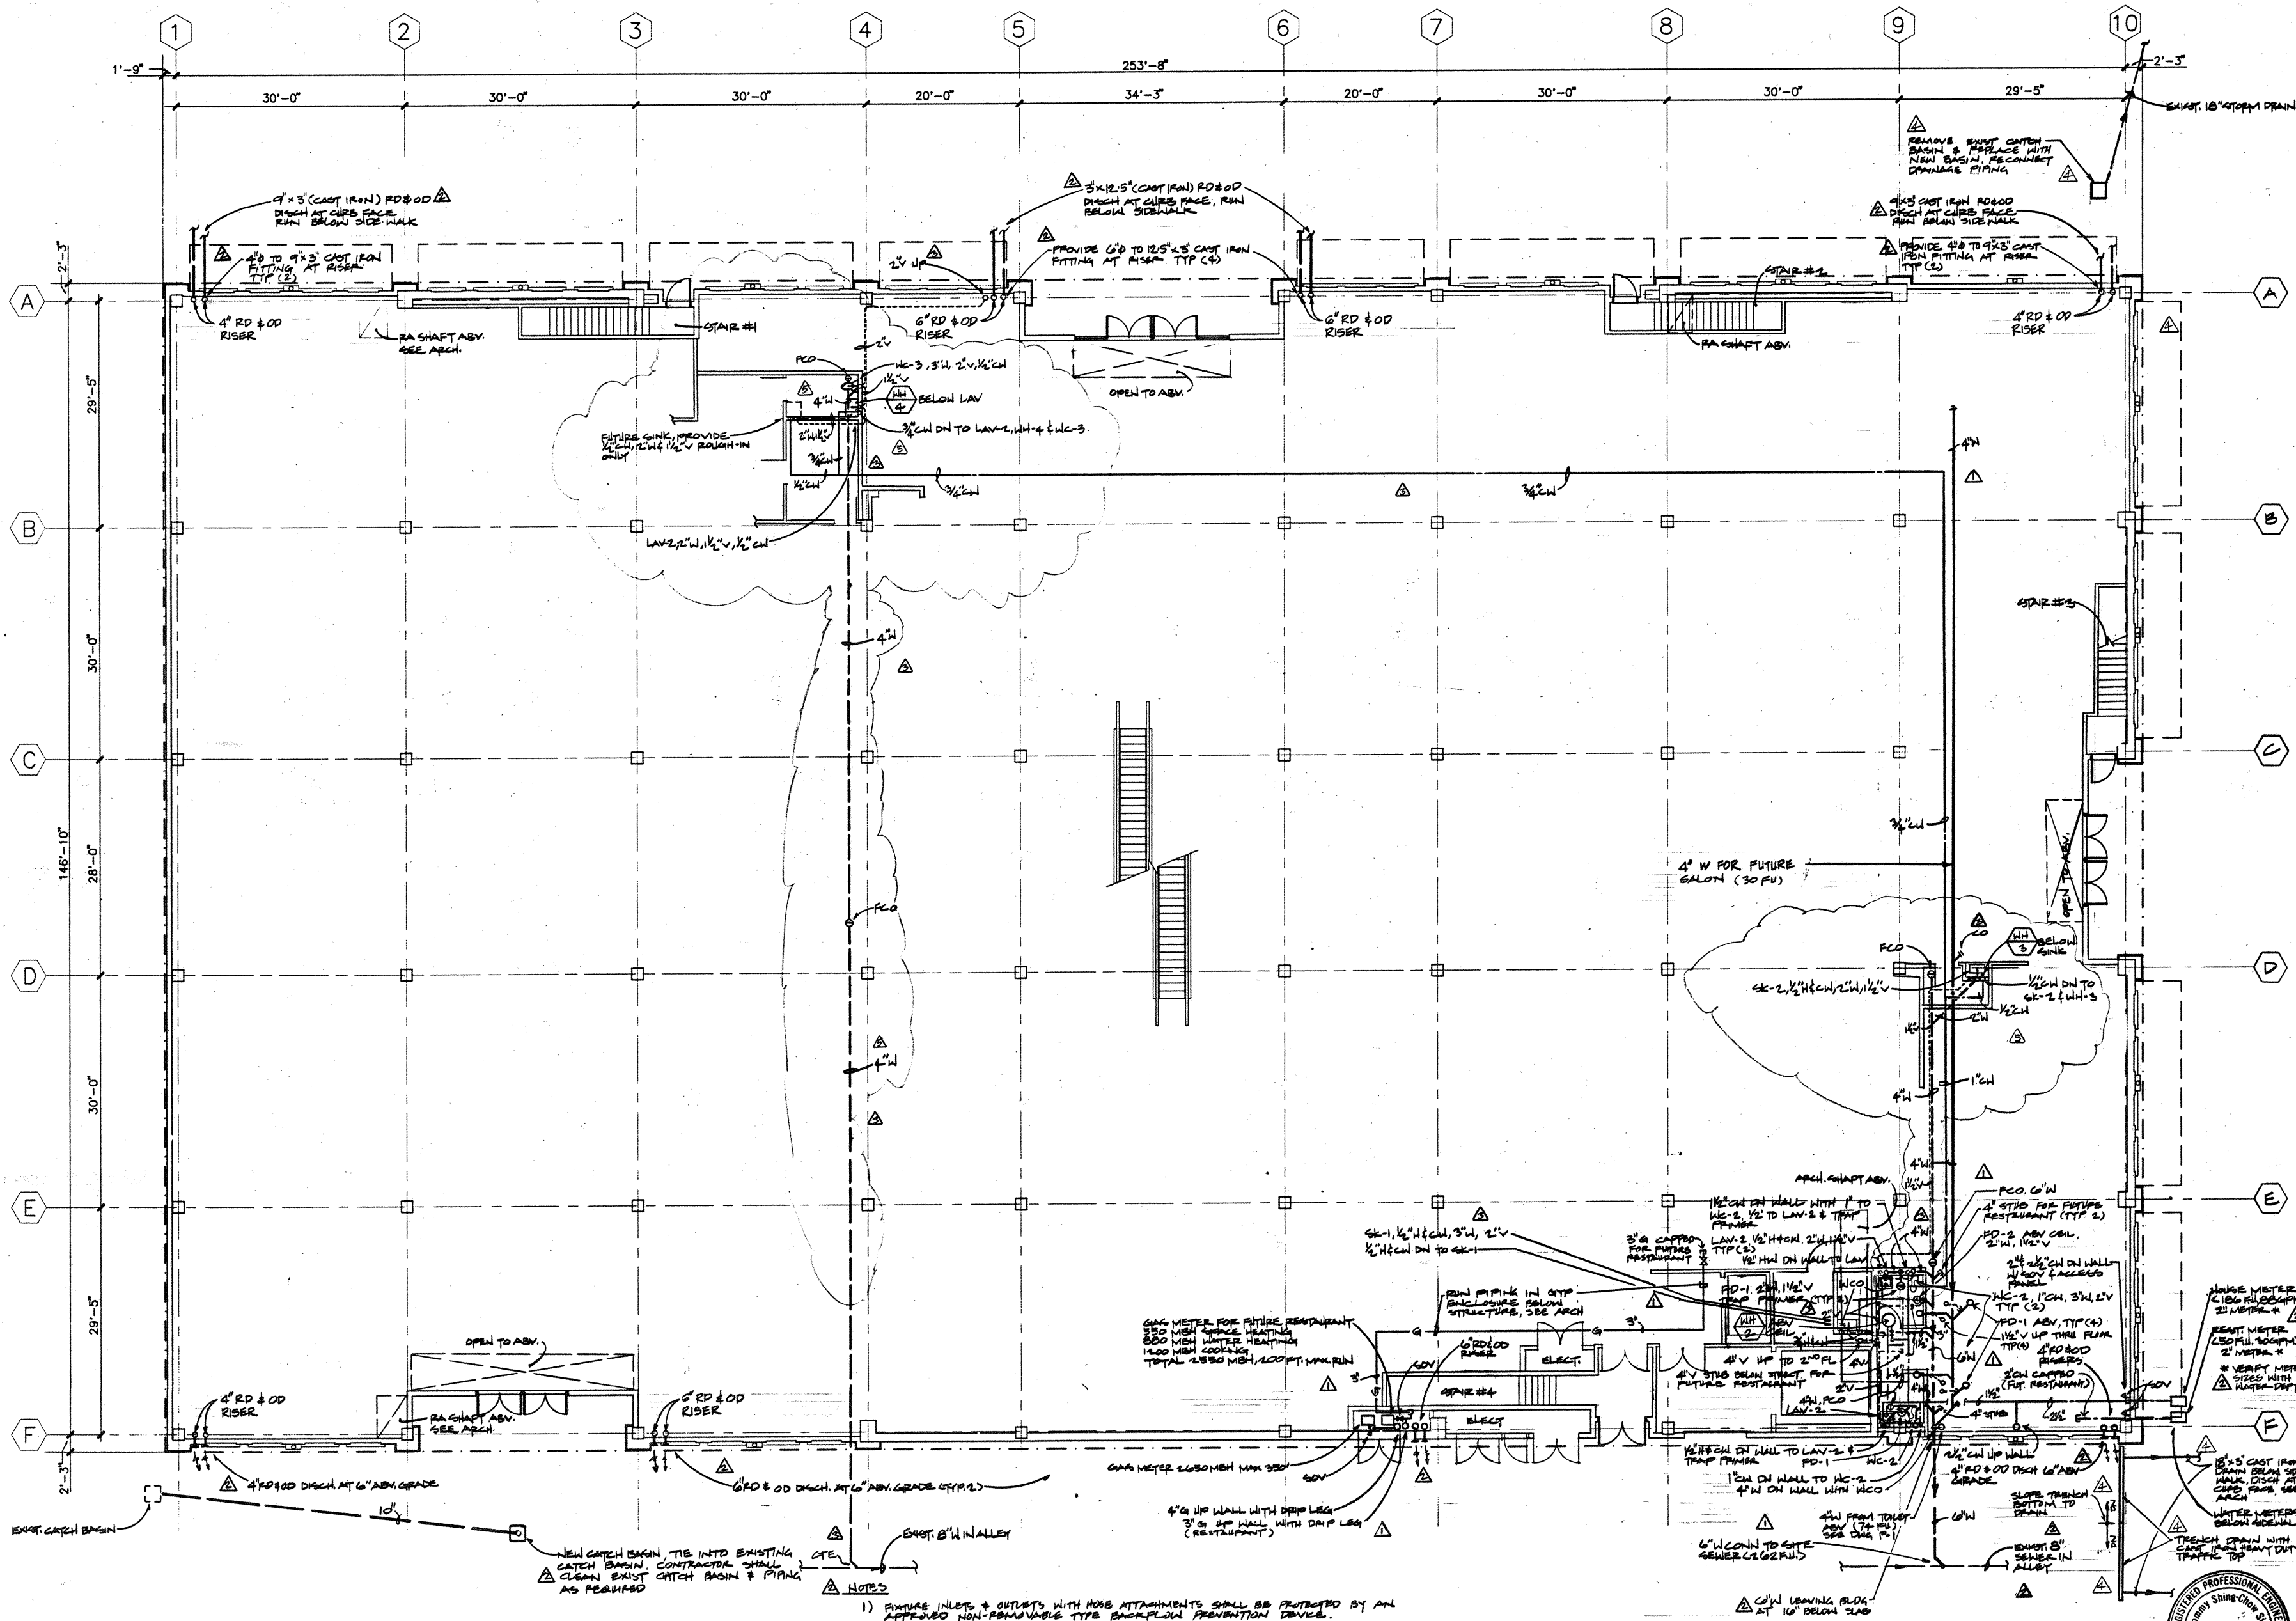


GROUND FLOOR PLAN-PLUMBING

1

- NOTES**
- 1) FIXTURE INLETS & OUTLETS WITH HOSE ATTACHMENTS SHALL BE PROTECTED BY AN APPROVED NON-FRAME VALVE TYPE BACKFLOW PREVENTION DEVICE.
 - 2) WATER CLOSET BOWLS FOR PUBLIC USE SHALL BE ELONGATED BOWLS EQUIPPED WITH OPEN-FRONT SEATS.

REFERENCE NORTH

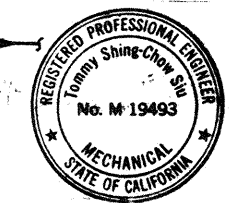

SHELL CONSTRUCTION SET

PROJ
 JOB#
 DSK
 FILE
 DATE